

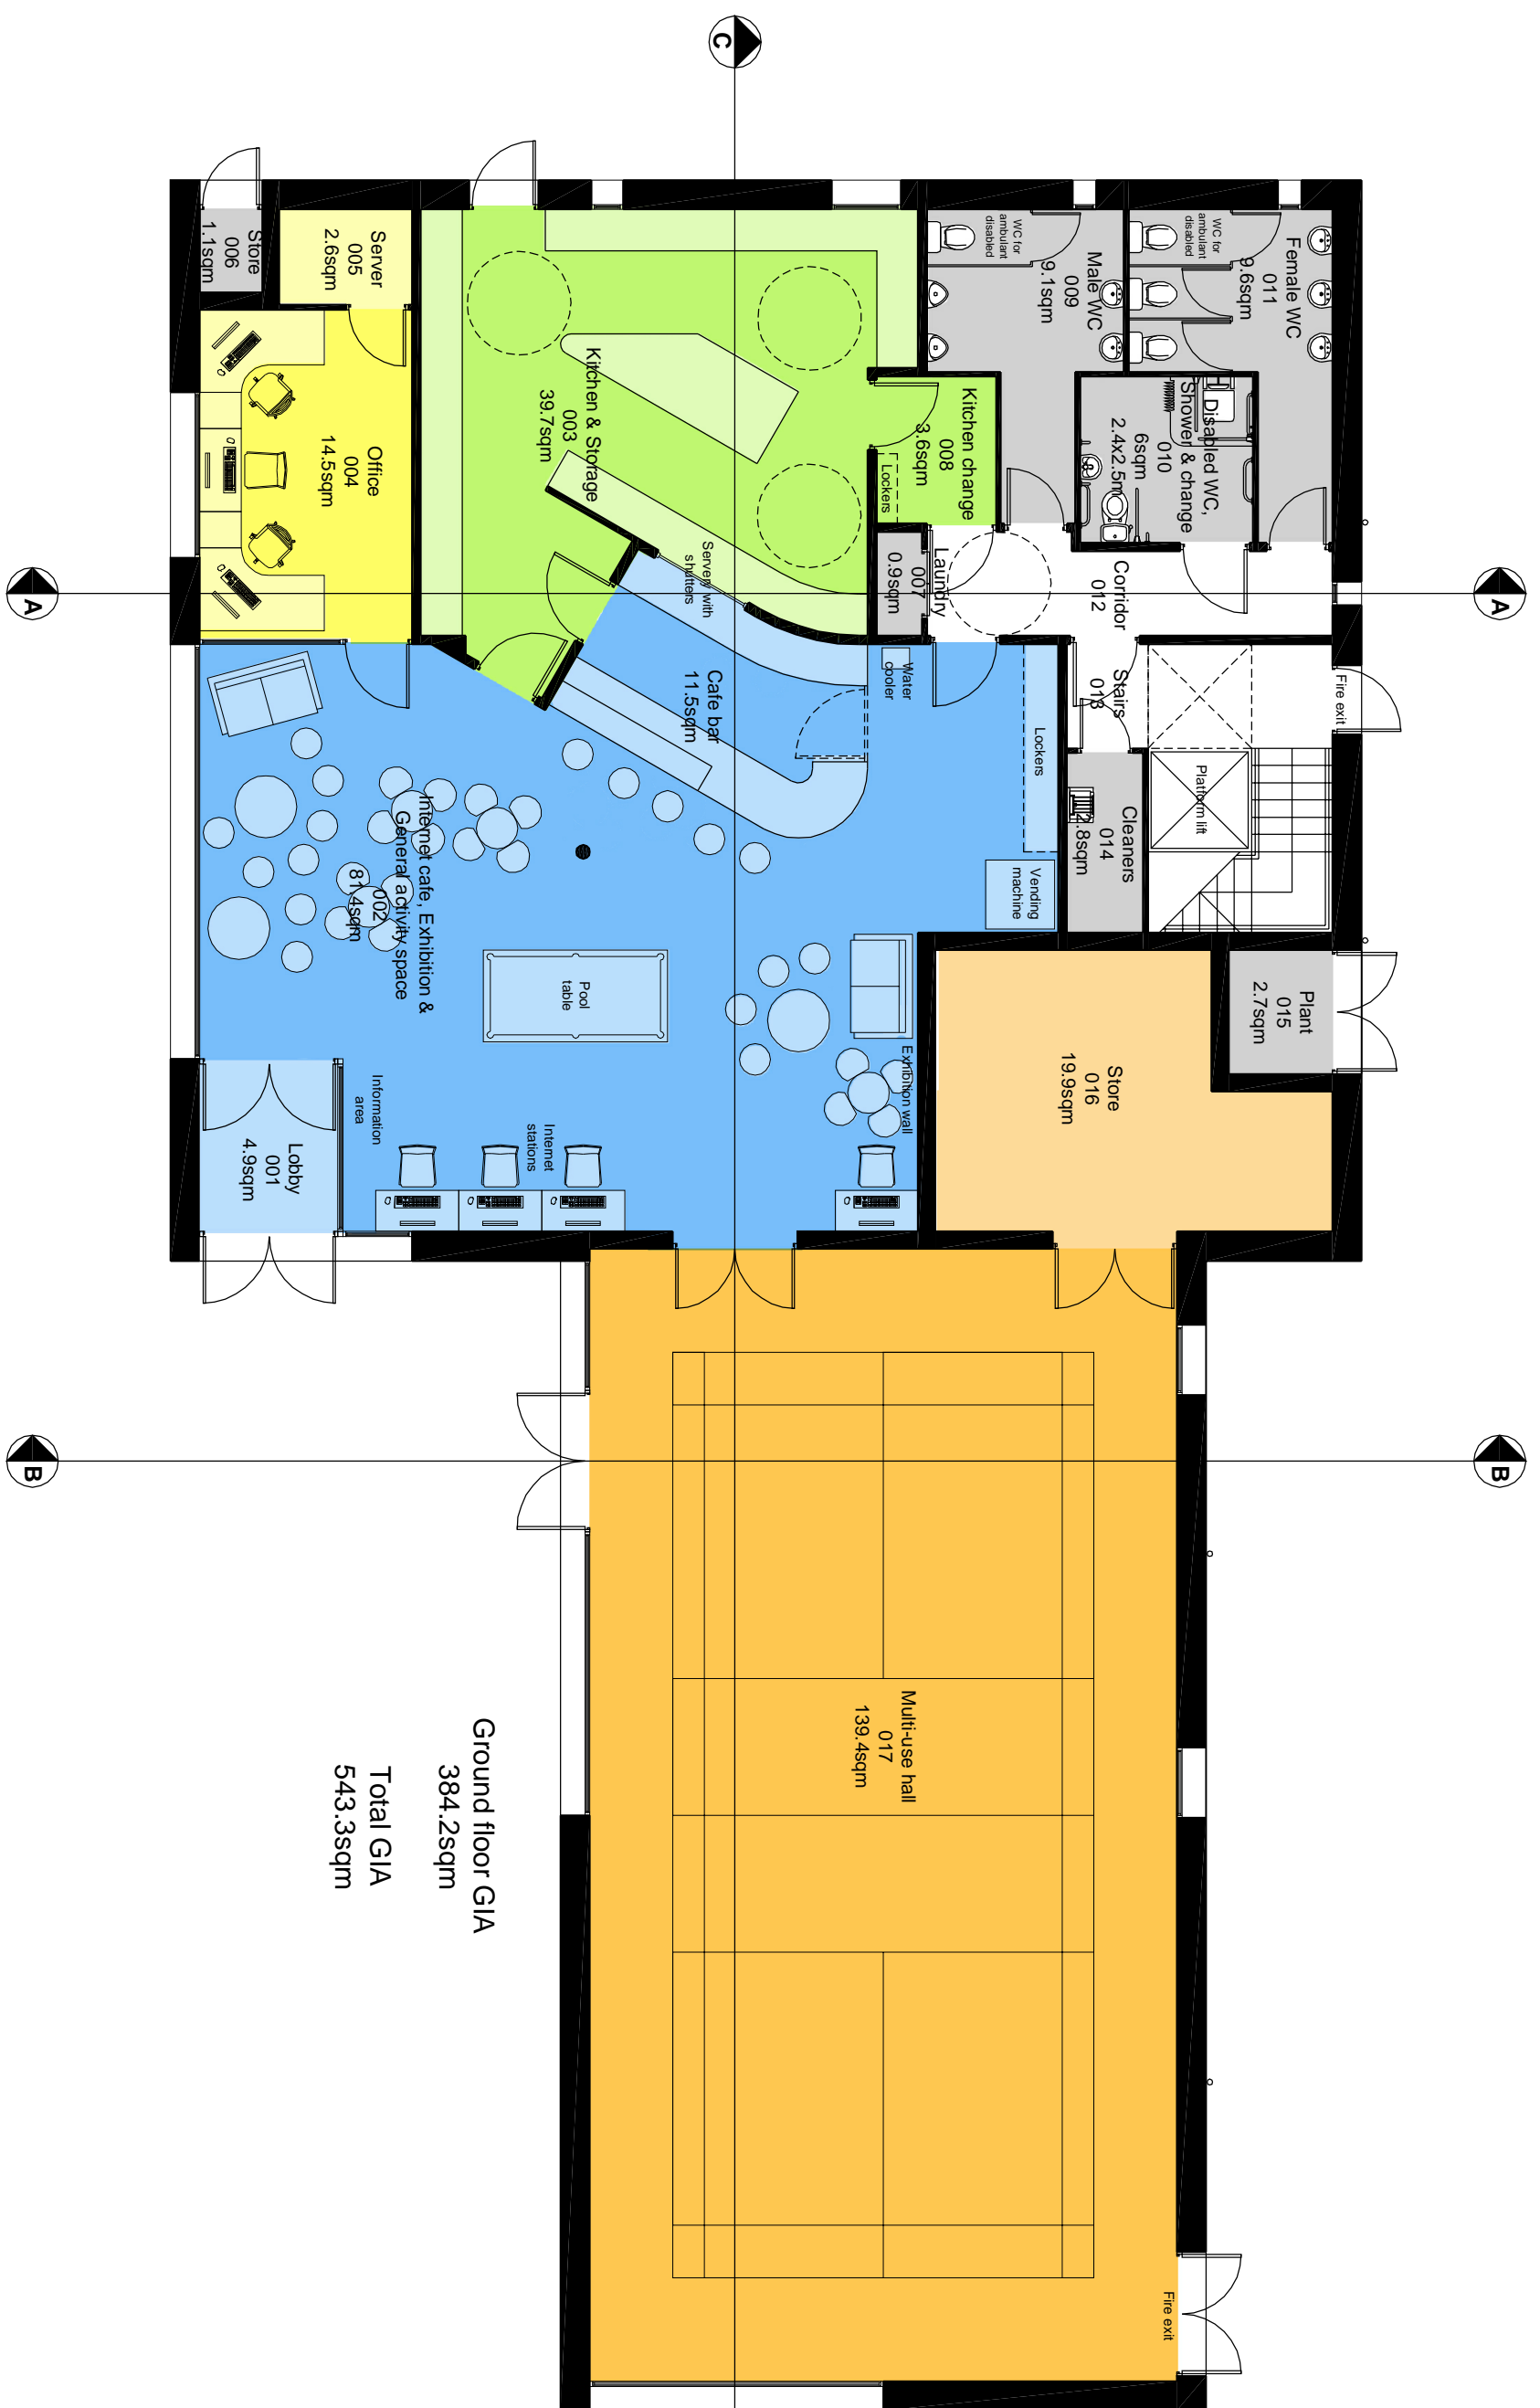
 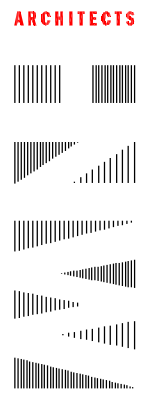


Rev / Amendments	By	Chkd	Date
H PLANNING SUBMISSION	JD	AC	14/12/09

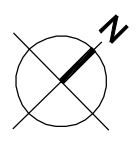

Ground floor GIA
 384.2sqm
 Total GIA
 543.3sqm



HWW Architects, 11 West Palace, Chichester, West Sussex, PO19 1TB
 Tel: 01243 533000 Fax: 01243 533011 Email: hww@hww.co.uk www.hww.co.uk

Project
**PHOENIX CENTRE
 YOUTH CLUB at BOGNOR REGIS
 COMMUNITY COLLEGE CAMPUS**

Drawing Title
**GROUND FLOOR PLAN
 AS PROPOSED**

Drawing Status
PLANNING SUBMISSION

Scale
 1:100 @ A3

Checked By
 AC
 Date
 SEPT 2009

Project No.
 08015
 Drawing No.
 P020
 Revision
 H